


ELECTRICAL LEGEND

LIGHT FIXTURES	RECEPTACLES		SWITCHES	SPECIAL OUTLETS & FIXTURES	
⊕ SURFACE MOUNTED	⊕ DUPLEX	⊕ ^W WEATHERPROOF	⊕ SINGLE-POLE	⊕ TELEVISION	⊕ SMOKE DETECTOR (WALL MOUNTED)
○ RECESSED	⊕ QUADRUPLX	⊕ ^{GF} GROUND-FAULT CIRCUIT-INTERRUPTER	⊕ THREE-WAY	⊕ TELEPHONE	⊕ DOOR BELL
▭ FLUORESCENT	⊕ SPLIT-WIRED DUPLEX	⊕ CEILING DUPLEX	⊕ DIMMER	⊕ EXHAUST FAN	⊕ CHIMES
⊕ FLOODS	⊕ SPECIAL PURPOSE	⊕ FLOOR DUPLEX		⊕ SMOKE DETECTOR (CEILING MOUNTED)	⊕ PANEL BOX
⊕ FAN / LIGHT	⊕ 220 VOLT			⊕ SMOKE / CARBON MONOXIDE DETECTOR	

NOTE
UNLESS OTHERWISE NOTED
ALL WINDOWS & DOORS TO BE
SET AT 4'-8" HEADER HEIGHT

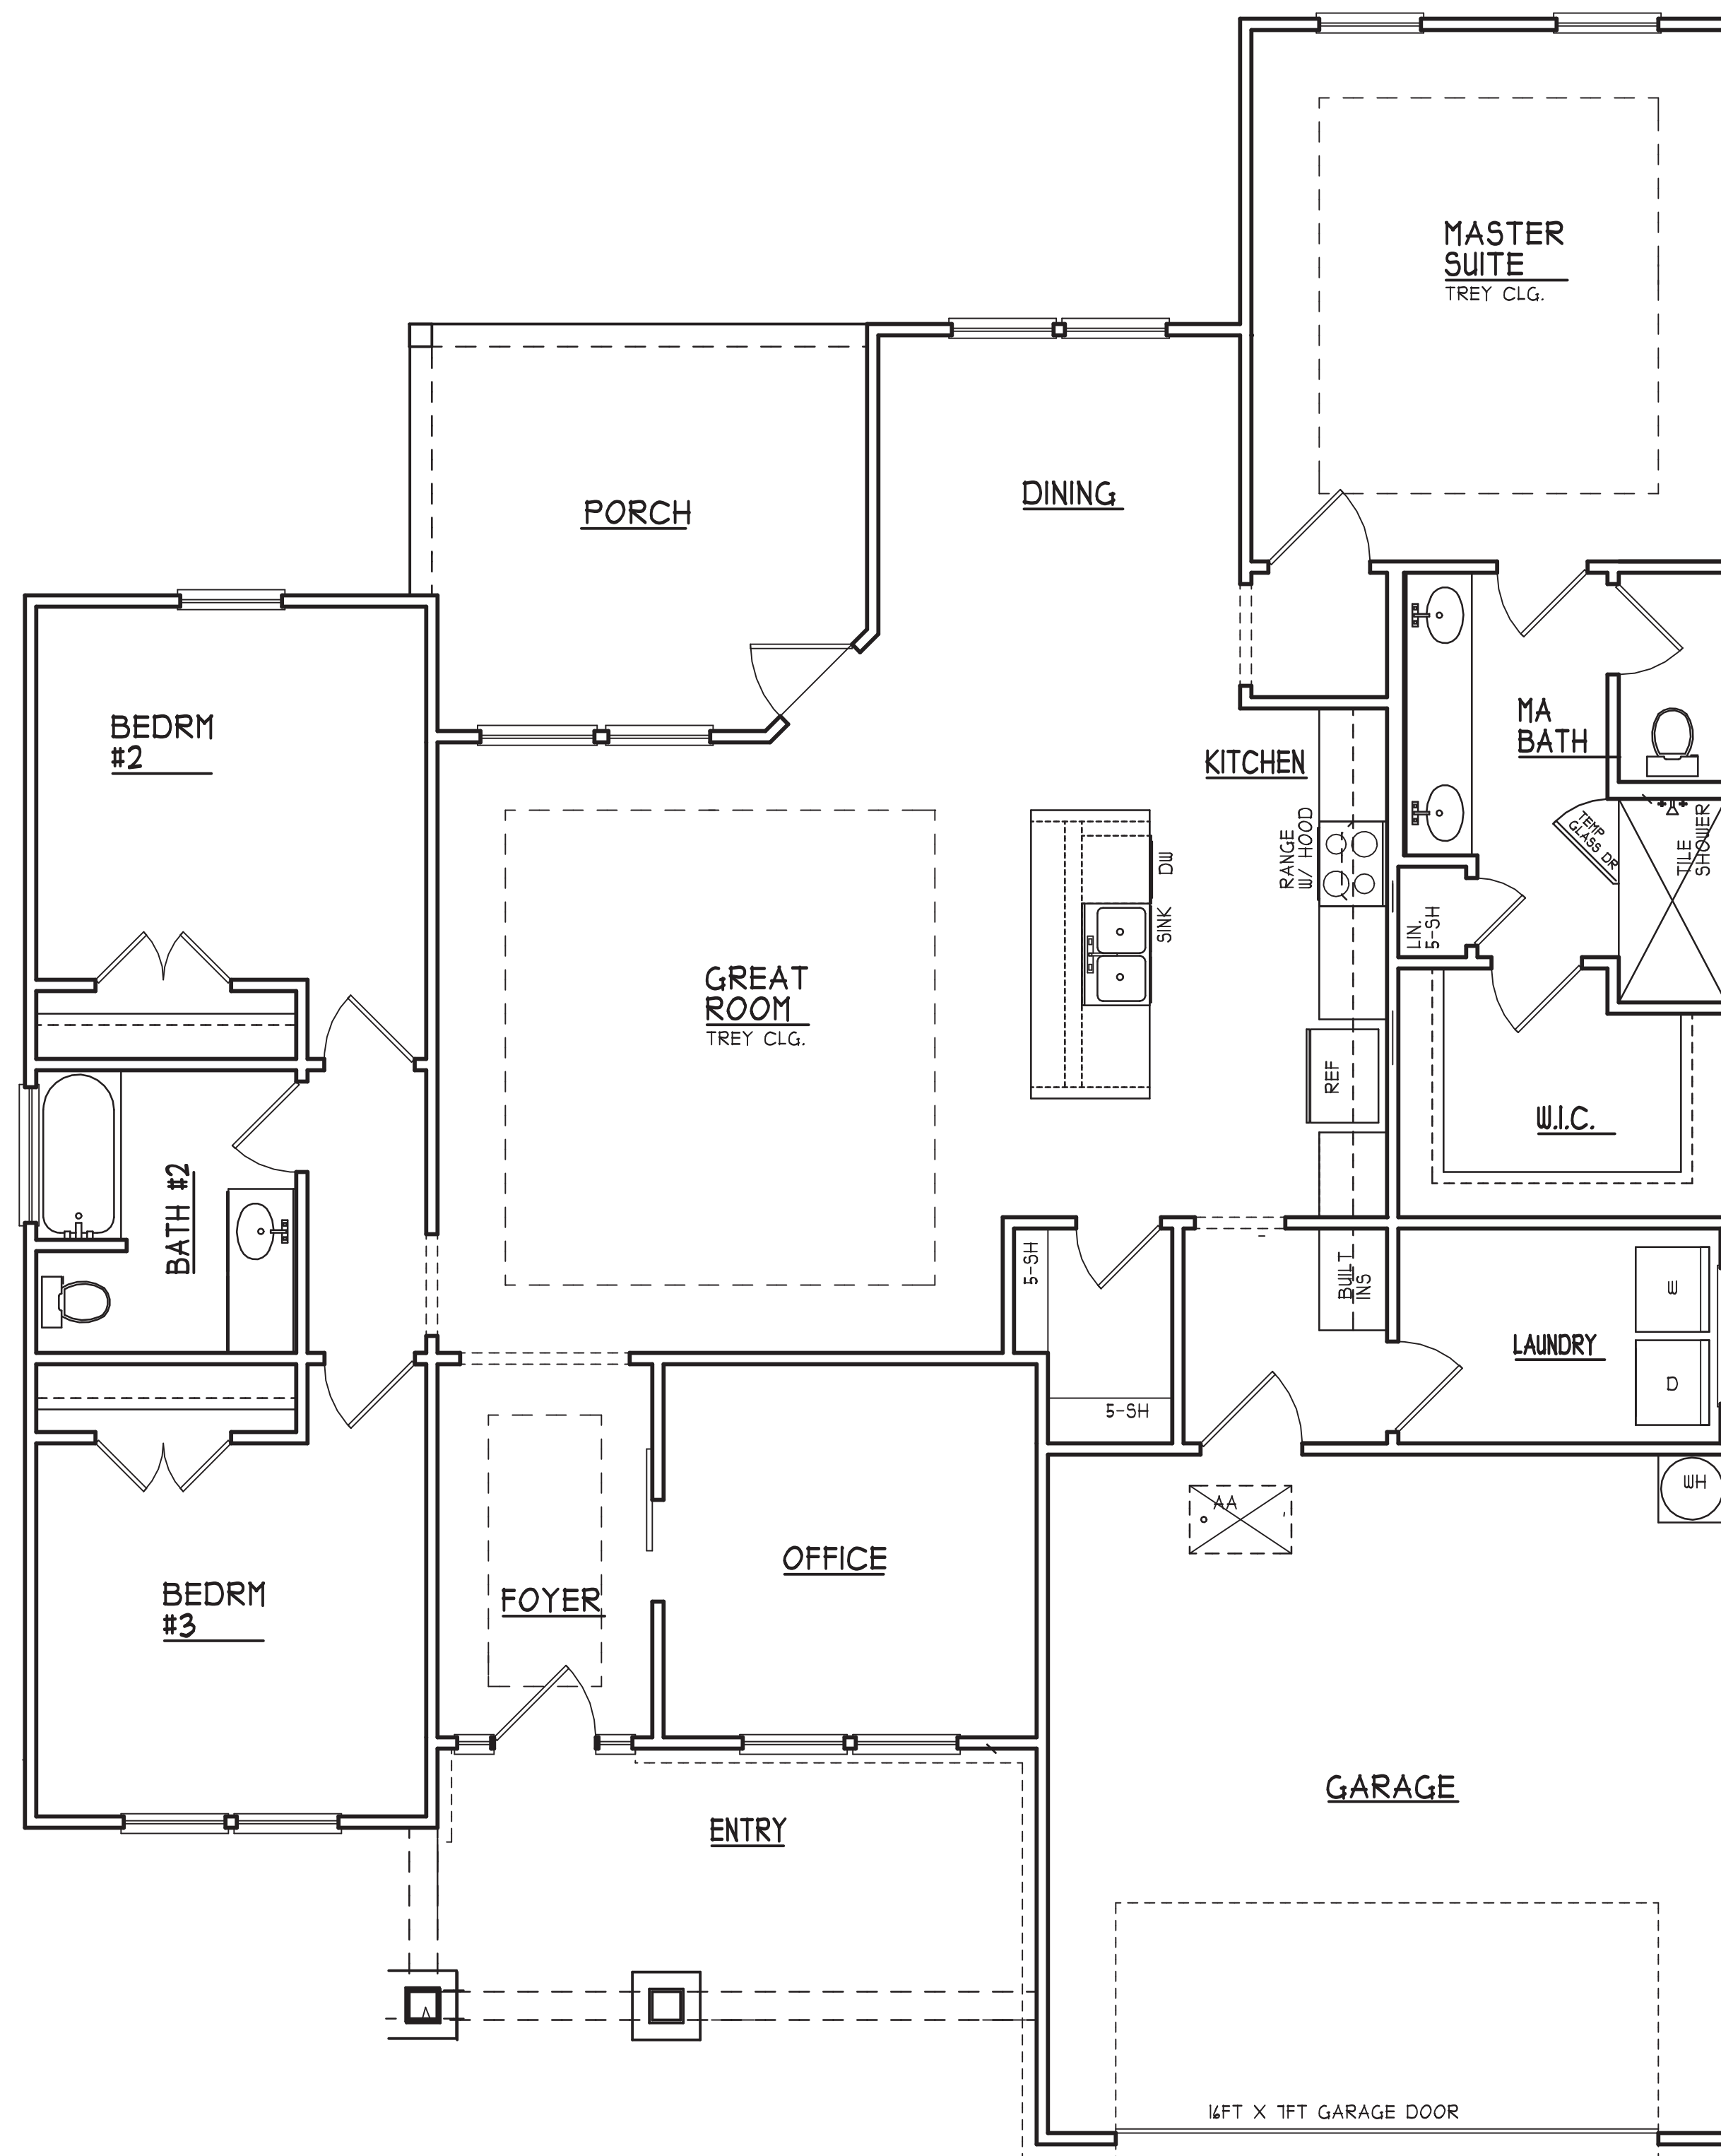

ELECTRICAL PLAN
SCALE: 1/4"=1'-0"

FLOOR PLAN
SCALE: 1/8"=1'-0"

AREA	SQ. FT.
LIVING H/C	1,840
GARAGE	417
ENTRY	140
PORCH	154
TOTAL UNDER ROOF	2,591

THE PARRISH GROUP INC.
The Madison

FLOOR PLAN & ELECTRICAL PLAN

House #8 R

SHEET

3

CUSTOM
08/15/2022
Bell's Drafting & Design
(850) 363-6004
BELLSDRAFTING@GMAIL.COM